


# CONSTRUCTION PLAN

## DRIVING RANGE

### CITY OF HARRISONBURG GOLF COURSE

HARRISONBURG, VIRGINIA

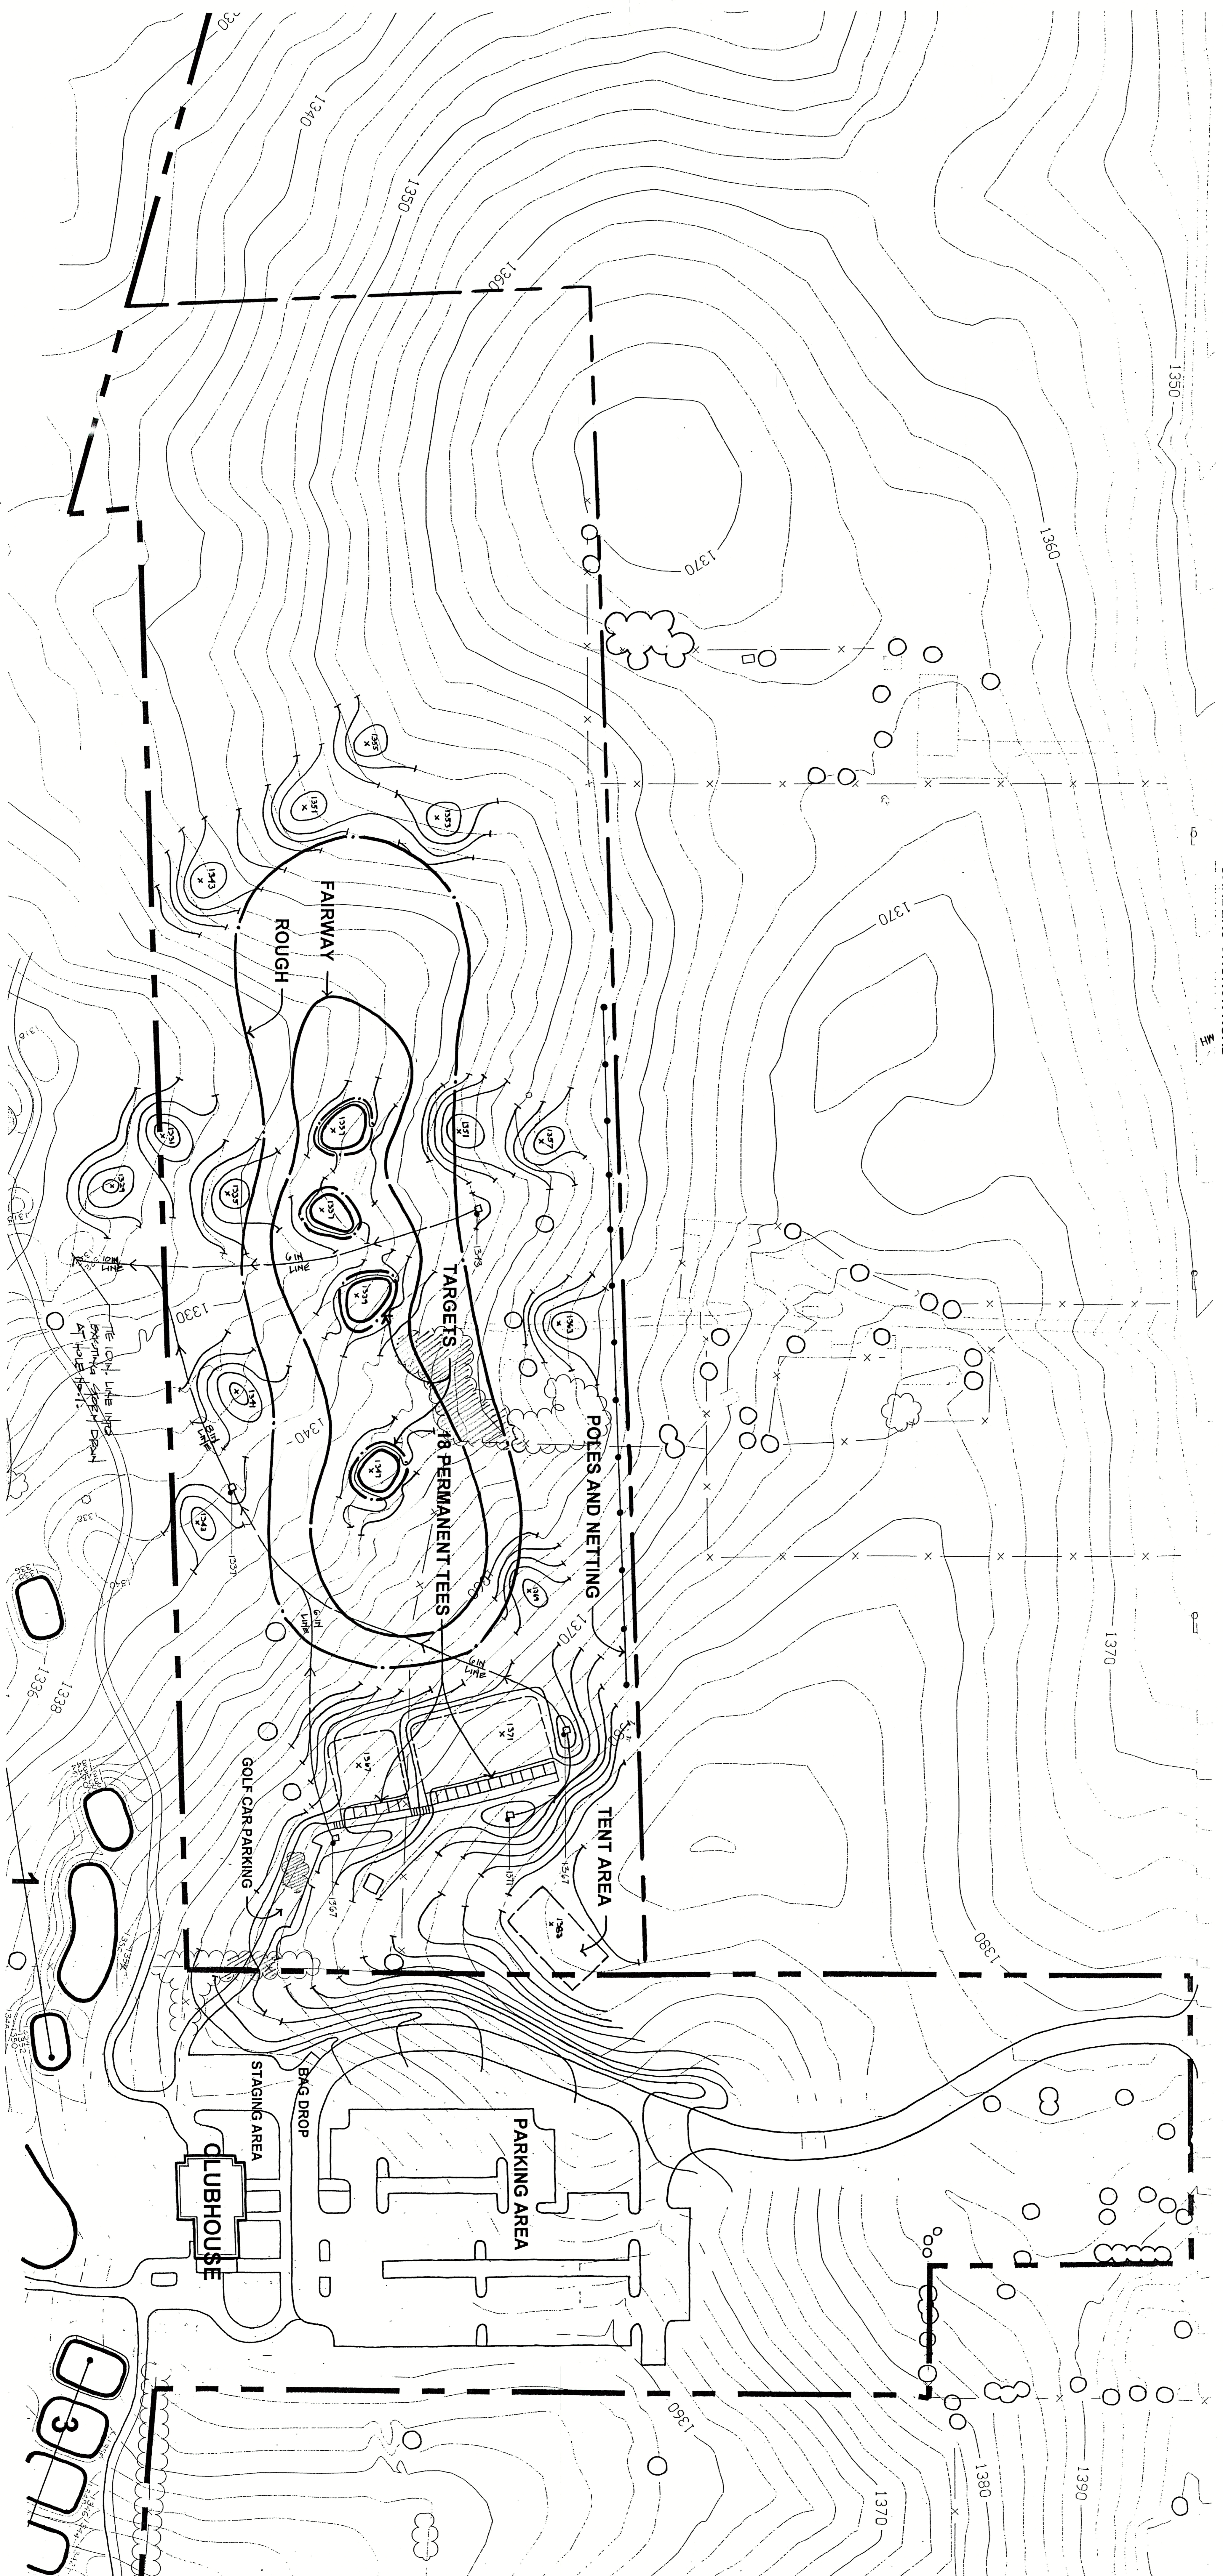

- #### KEY TO SYMBOLS
- EXISTING TOPOGRAPHY
  - GRADING FOR GOLF COURSE FEATURES
  - TEE COMPLEX WITH PROPOSED ELEVATION AND STAKE IN THE FIELD
  - TARGETS WITH PROPOSED ELEVATION AND STAKE IN THE FIELD
  - MOUNDS WITH PROPOSED ELEVATIONS
  - GRASS HOLLOW WITH PROPOSED ELEVATIONS AND 6-INCH DRAIN INLET AND LINE

SCALE: 1 INCH = 50 FEET

DATE: JANUAR / 2001


W.R. LOVE  
GOLF COURSE ARCHITECTURE  
7309 Baltimore Avenue  
College Park, Maryland 20740

# GRASSING PLAN

## DRIVING RANGE

### CITY OF HARRISONBURG GOLF COURSE

HARRISONBURG, VIRGINIA

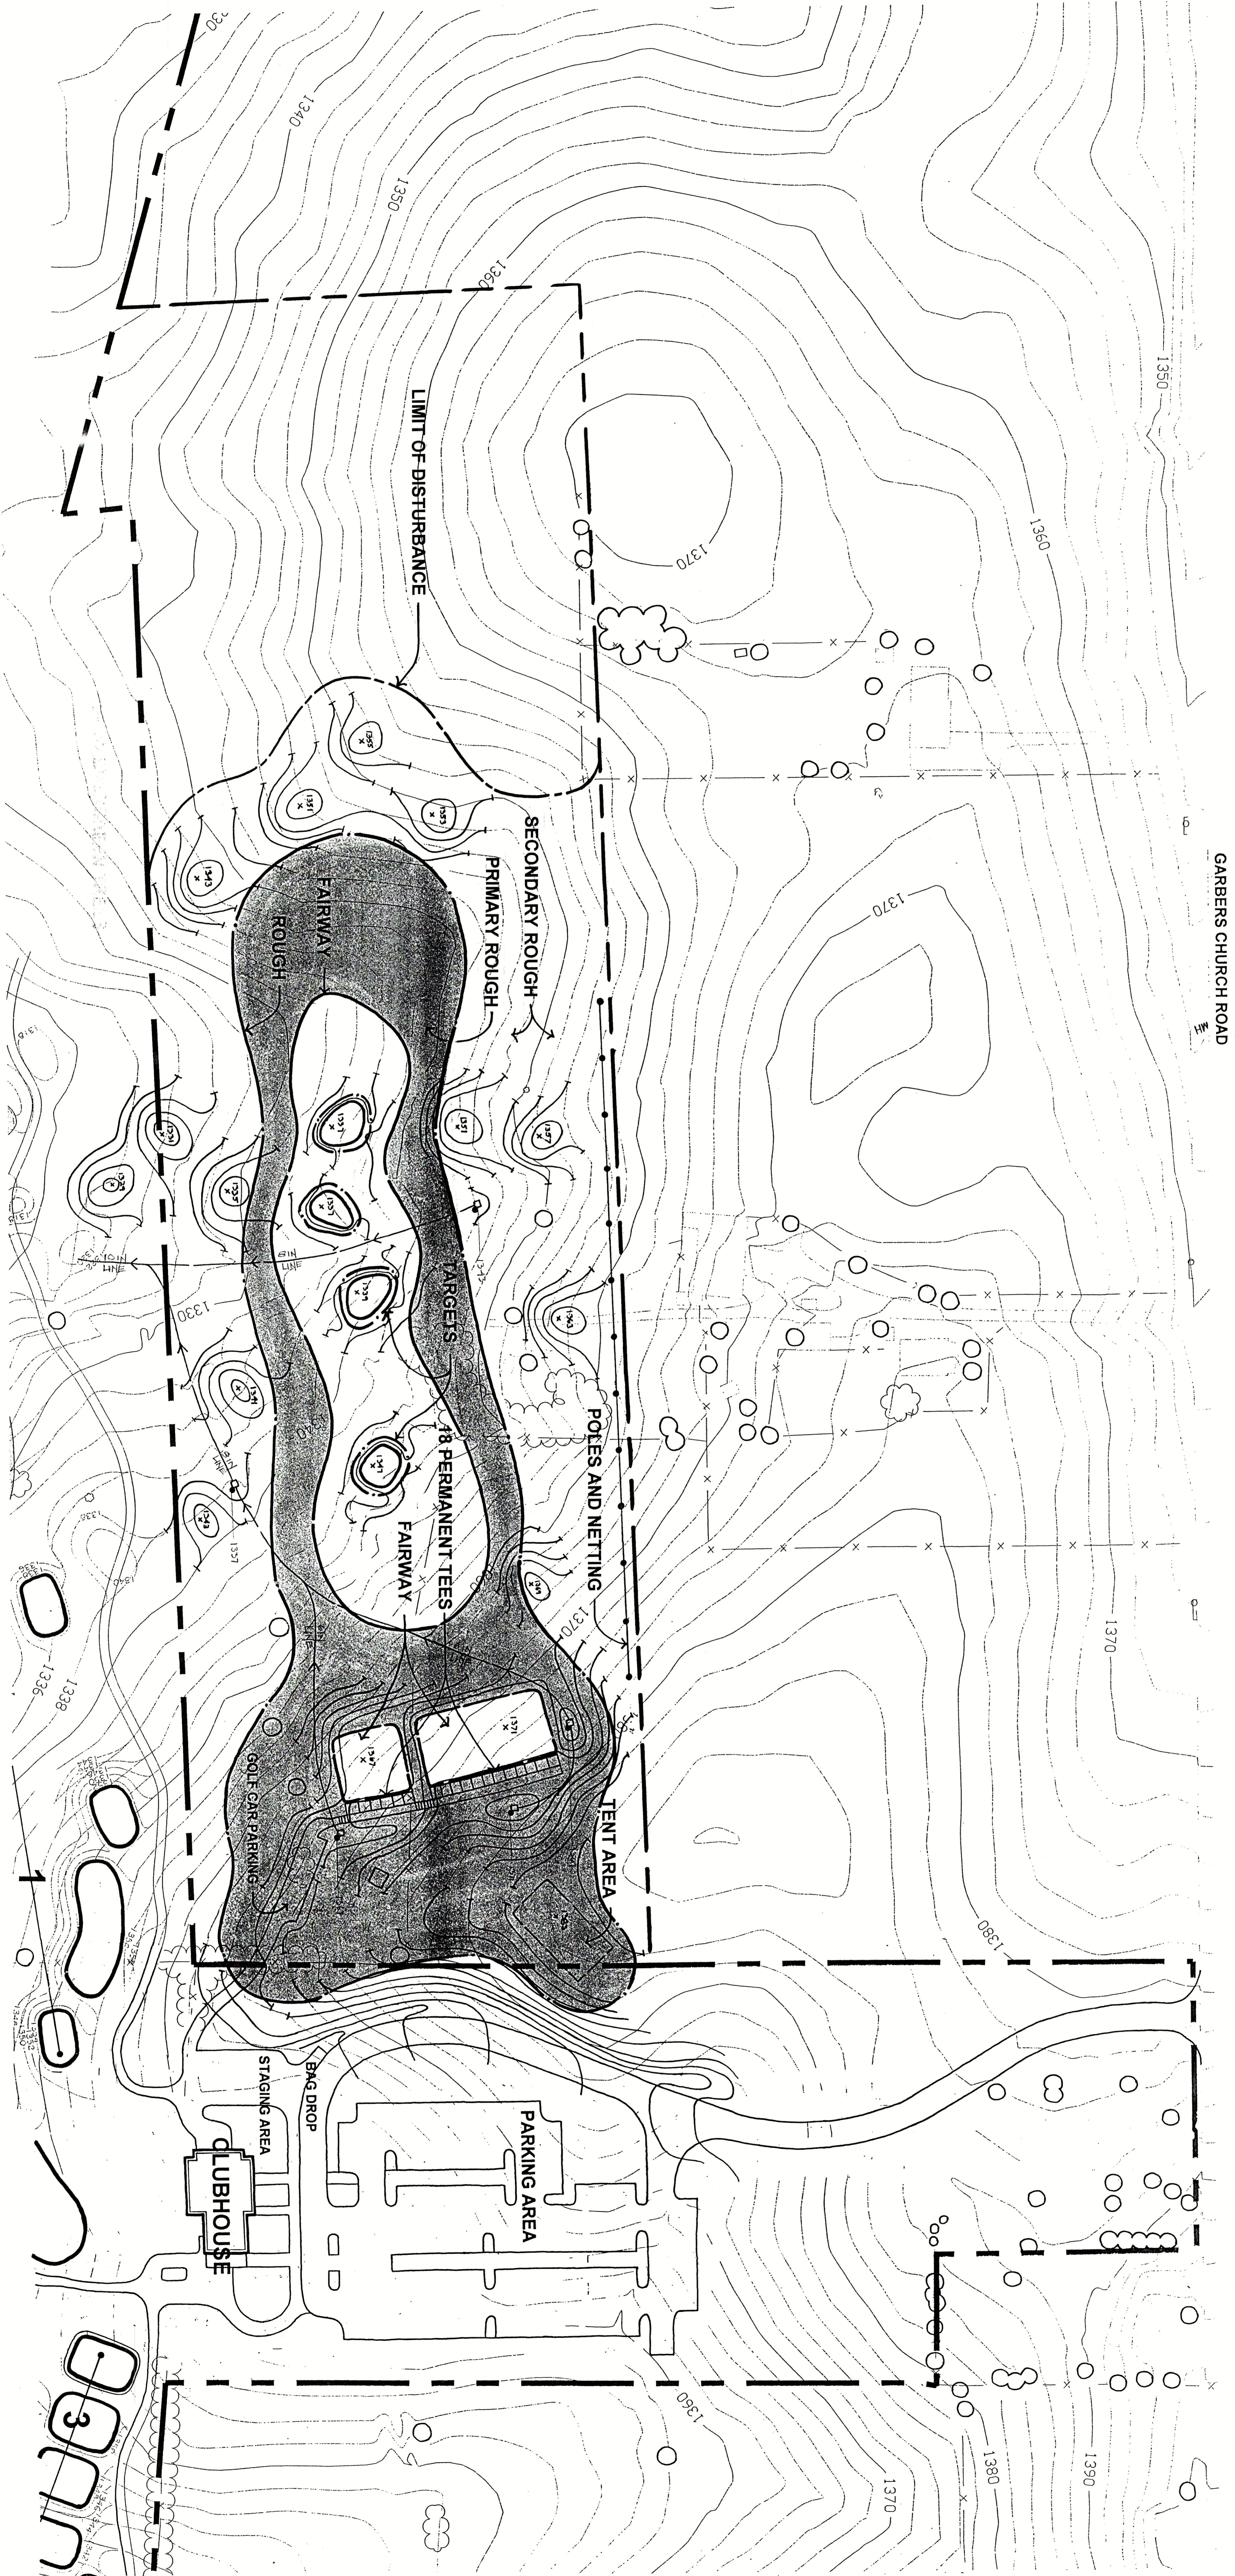


SCALE: 1 INCH = 50 FEET

DATE: JANUARY, 2001



W.R. LOVE  
GOLF COURSE ARCHITECTURE  
7309 Baltimore Avenue  
College Park, Maryland 20740

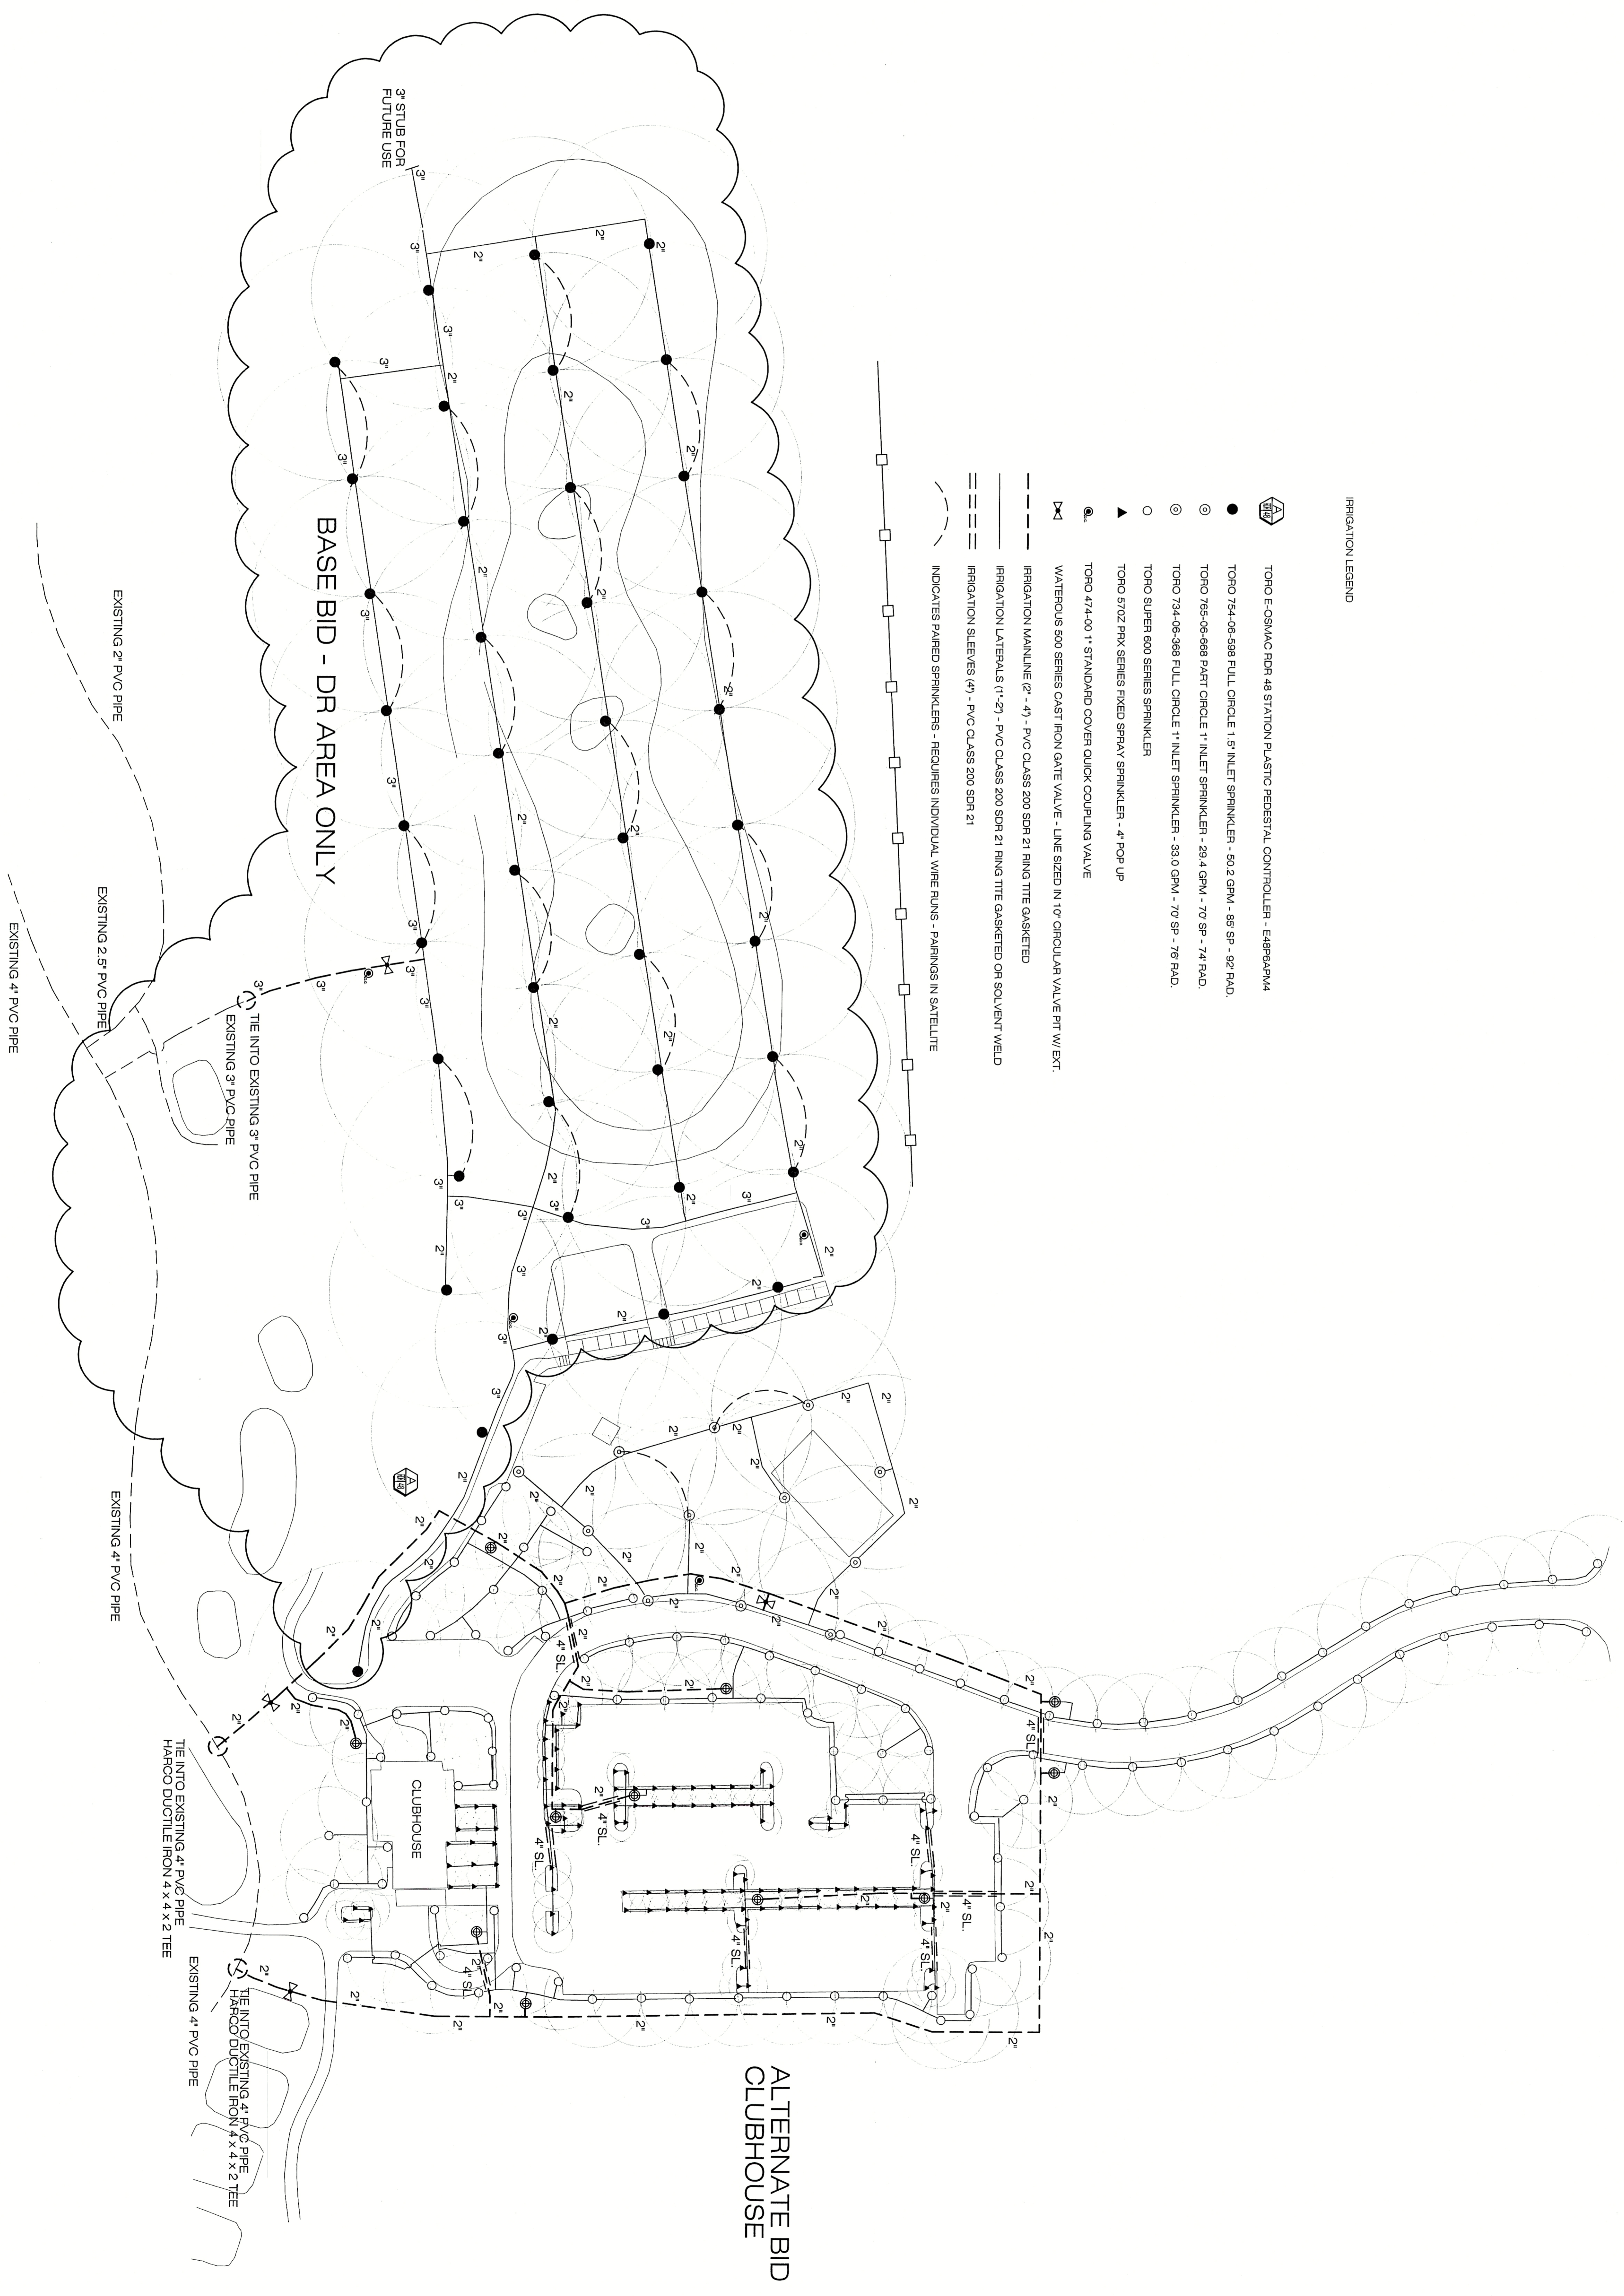

IRRIGATION LEGEND

- TORO E-CORMAC ROR 48 STATION PLASTIC MEDISTVAL CONTROLLER - E48R44M4
- TORO 754-06-088 FULL CIRCLE 1\" INLET SPRINKLER - 50.2 GPM - 85\" SP - 82\" RAD.
- TORO 755-06-088 PART CIRCLE 1\" INLET SPRINKLER - 29.4 GPM - 70\" SP - 74\" RAD.
- TORO 754-06-088 FULL CIRCLE 1\" INLET SPRINKLER - 53.0 GPM - 70\" SP - 76\" RAD.
- TORO SUPER 600 SERIES SPRINKLER
- ▲ TORO 570Z PPK SERIES FIXED SPRAY SPRINKLER - 4\" RCP UP
- ▲ TORO 474-00 1\" STANDARD COVER QUICK COUPLING VALVE
- WATERBUSH 500 SERIES CAST IRON GATE VALVE - LINE SIZED N 10\" CHICLAP VALVE PRT V/1 EXT.
- IRRIGATION MAINLINE (2\" - 4\" - PVC CLASS 200 SDR 21 RING TITE GASSETED
- IRRIGATION LATERALS (1\" - 2\" - PVC CLASS 200 SDR 21 RING TITE GASSETED OR SOLVENT WELD
- IRRIGATION SLEEVES (4\" - PVC CLASS 200 SDR 21
- INDICATES PAIRED SPRINKLERS - REQUIRES INDIVIDUAL WIRE RUNS - PARKINGS IN SATELLITE

DRAWINGS FOR:		CITY OF HARRISONBURG DRIVING RANGE HARRISONBURG, VIRGINIA	
SCALE: 1" = 50'		SPRINKLER LAYOUT	
DRAWN:	MDR	NO.	REVISION
APPROVED:		1	REVISED AS PER ARCHITECTS COMMENTS
FILENAME:	HARDR	2	REVISED AS PER ARCHITECTS COMMENTS
DATE:	02-13-01	BY	DATE
		MDR	03/01/01
		MDR	03/12/01

STI SMITH TURF & IRRIGATION CO.  
P.O. BOX 6377 • RICHMOND, VIRGINIA 23220  
TORO (804) 255-5404 • D I S T R I B U T O R S • (800) 752-7301

STI DESIGNS  
2109 Landon Avenue  
Petersburg, VA 23104  
Phone: (804) 255-5404

THE INFORMATION CONTAINED HEREIN IS FOR GENERAL INFORMATION ONLY AND IS NOT TO BE USED AS A BASIS FOR CONTRACTING OR FOR ANY OTHER PURPOSE. THE USER OF THIS INFORMATION SHALL BE RESPONSIBLE FOR OBTAINING ALL NECESSARY PERMITS AND FOR VERIFYING THE ACCURACY OF ALL INFORMATION. THE USER OF THIS INFORMATION SHALL BE RESPONSIBLE FOR OBTAINING ALL NECESSARY PERMITS AND FOR VERIFYING THE ACCURACY OF ALL INFORMATION.

# PLANTING PLAN


## DRIVING RANGE

### CITY OF HARRISONBURG GOLF COURSE

HARRISONBURG, VIRGINIA

SCALE: 1 INCH = 50 FEET

DATE: JANUARY 2001

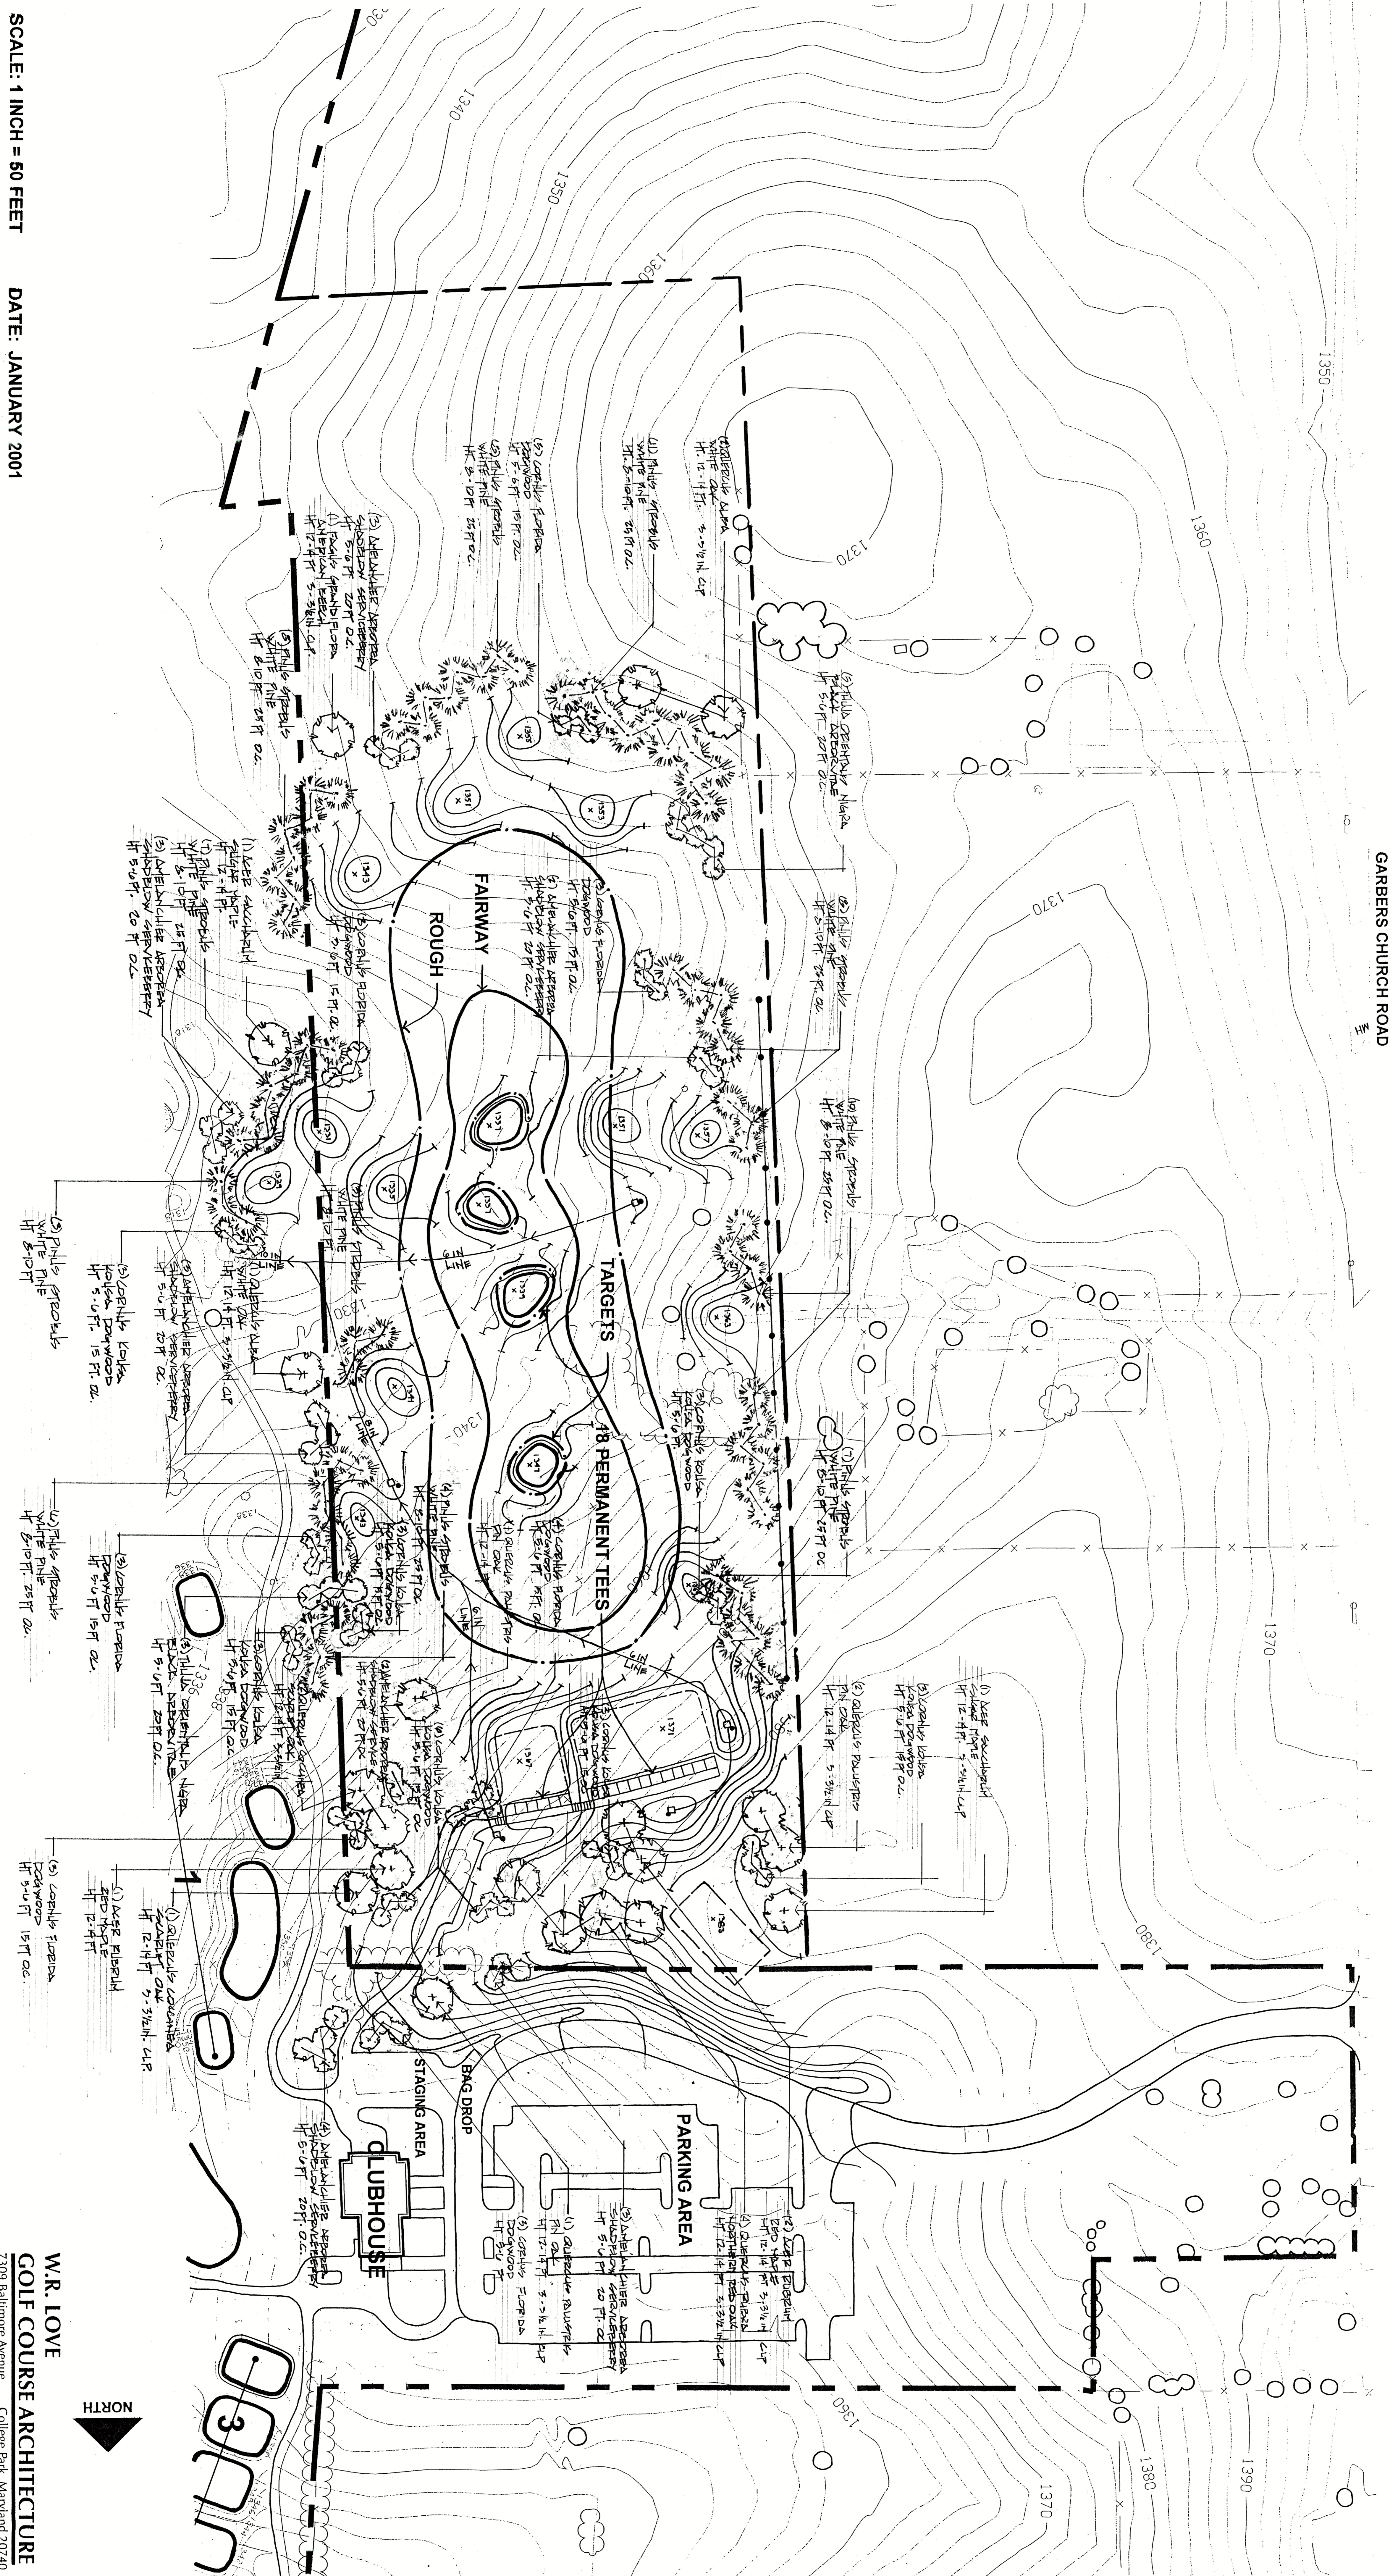

W.R. LOVE  
 GOLF COURSE ARCHITECTURE  
 7309 Baltimore Avenue  
 College Park, Maryland 20740